


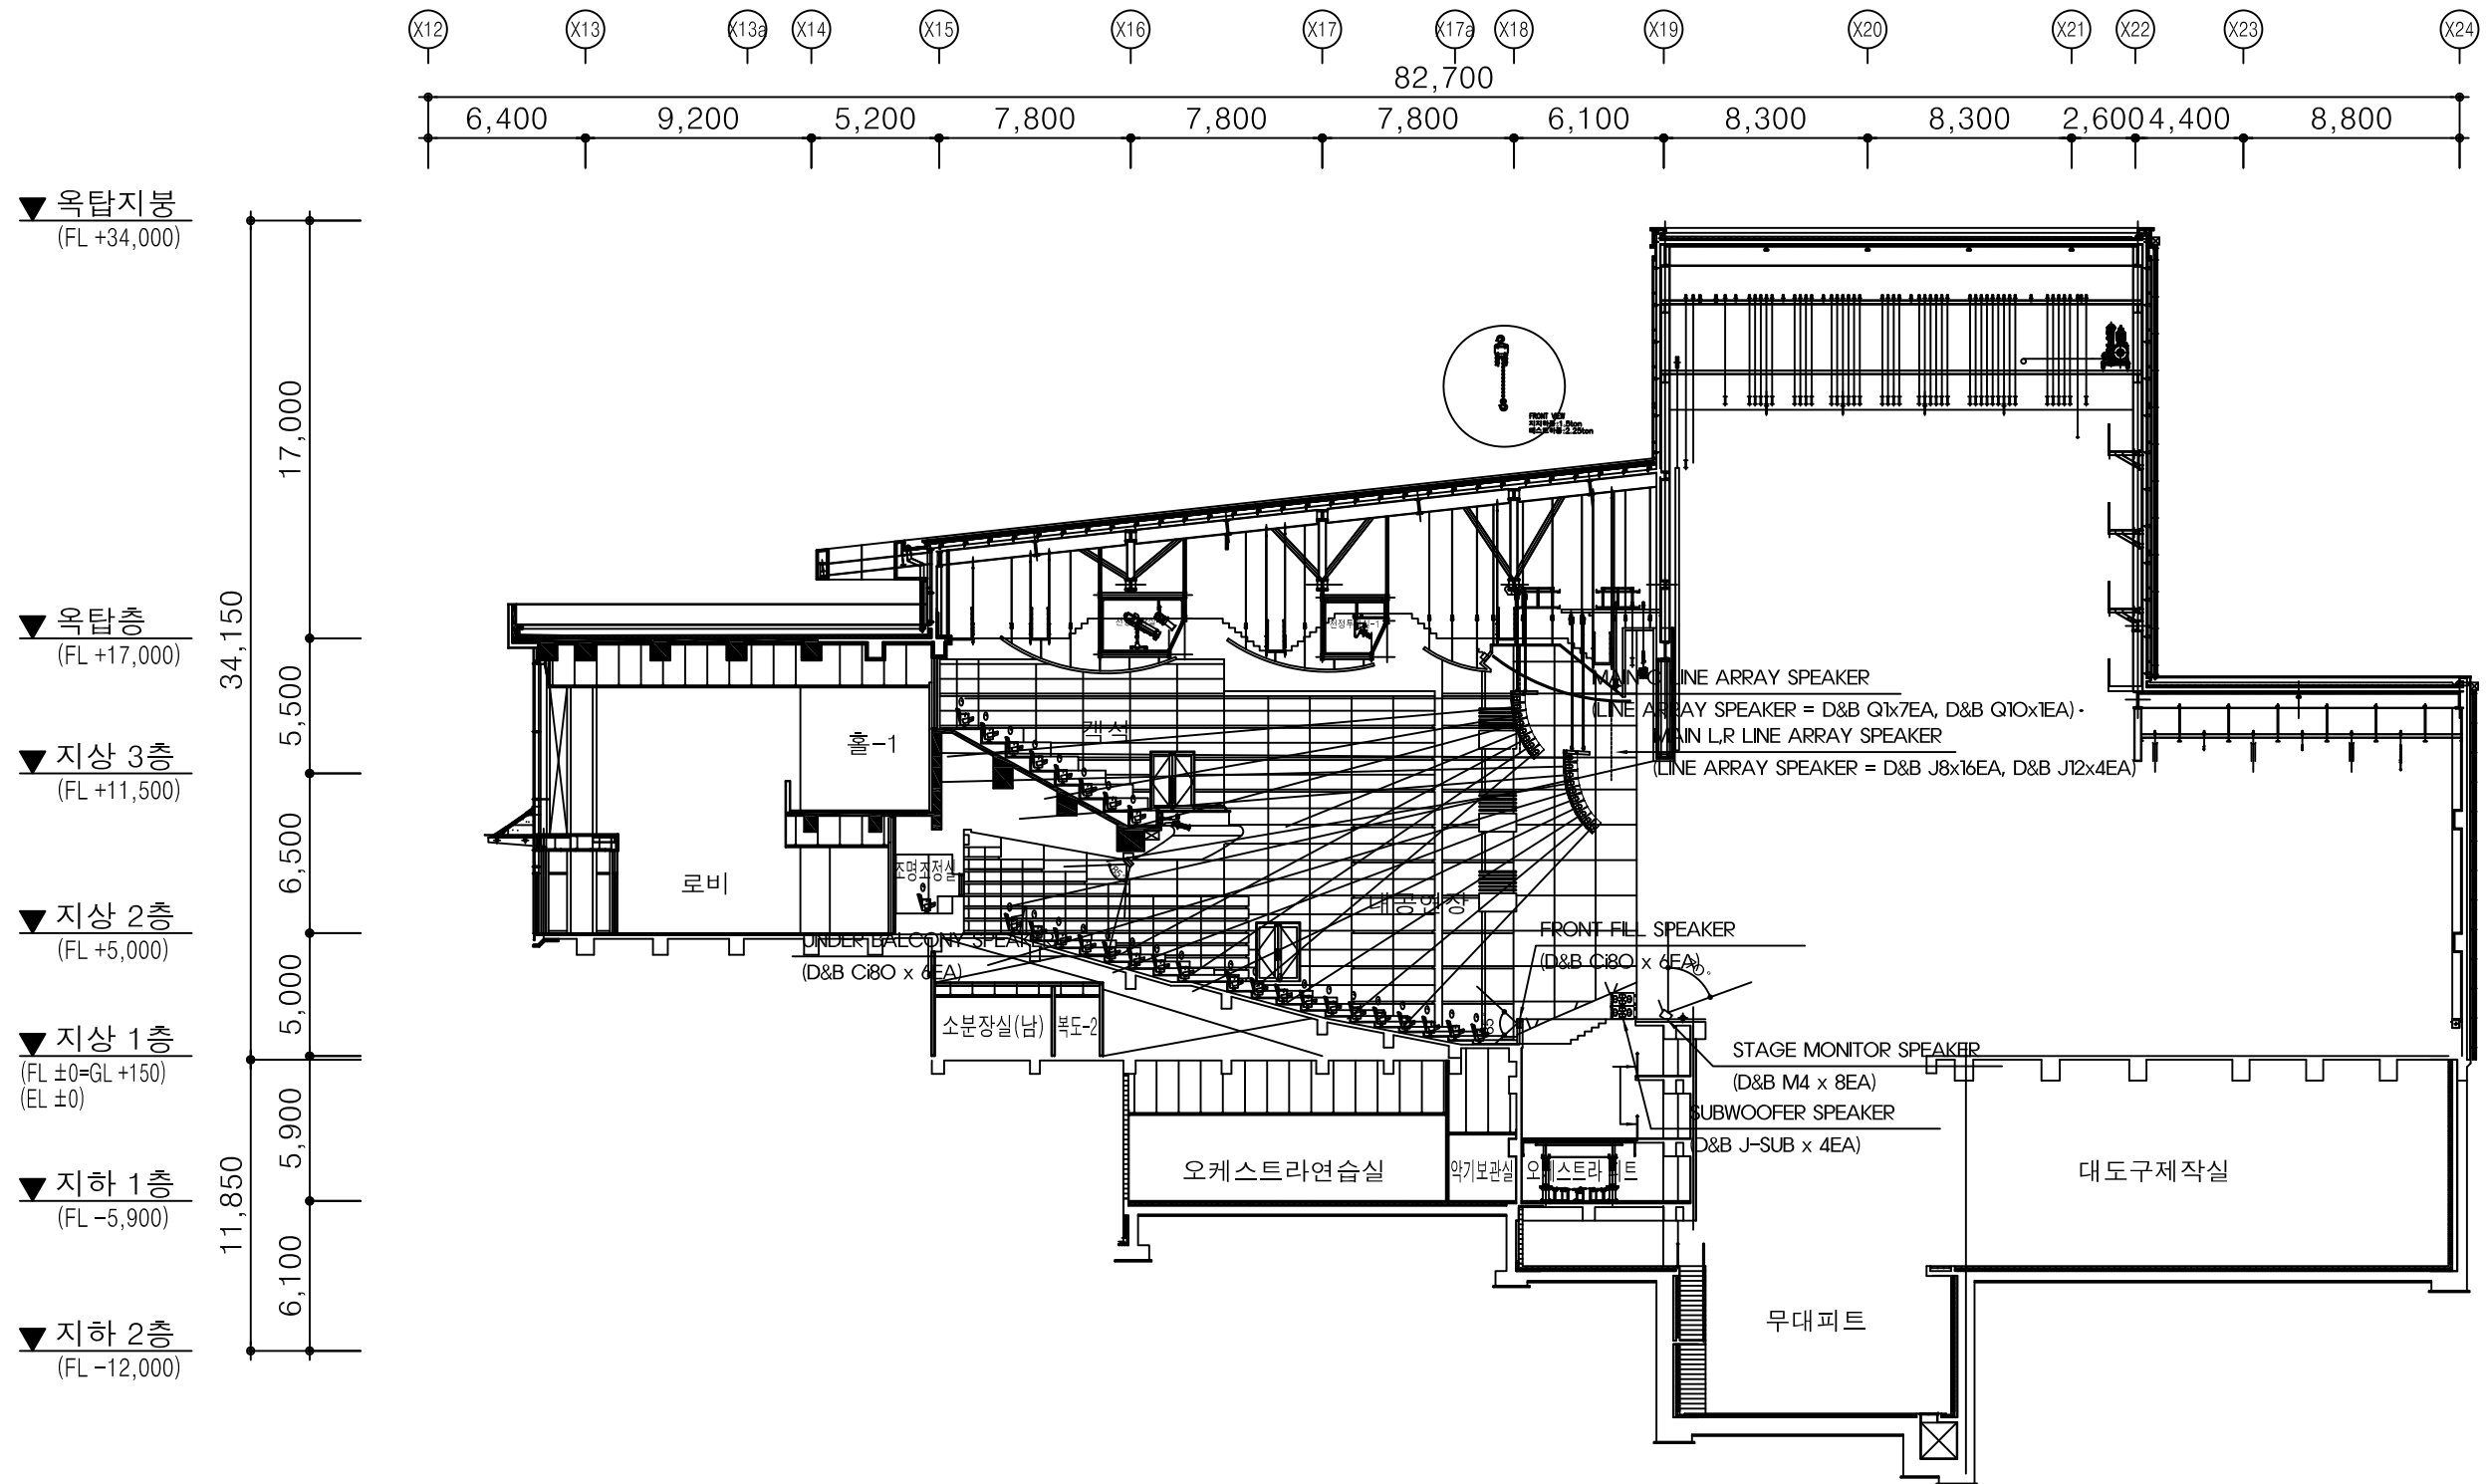


①
A- 대공연장 음향설비 MAIN SPEAKER 단면도

축척 : 1/150(A1)
: 1/300(A3)

대공연장
음향설비 단면도

150
300

SS-005

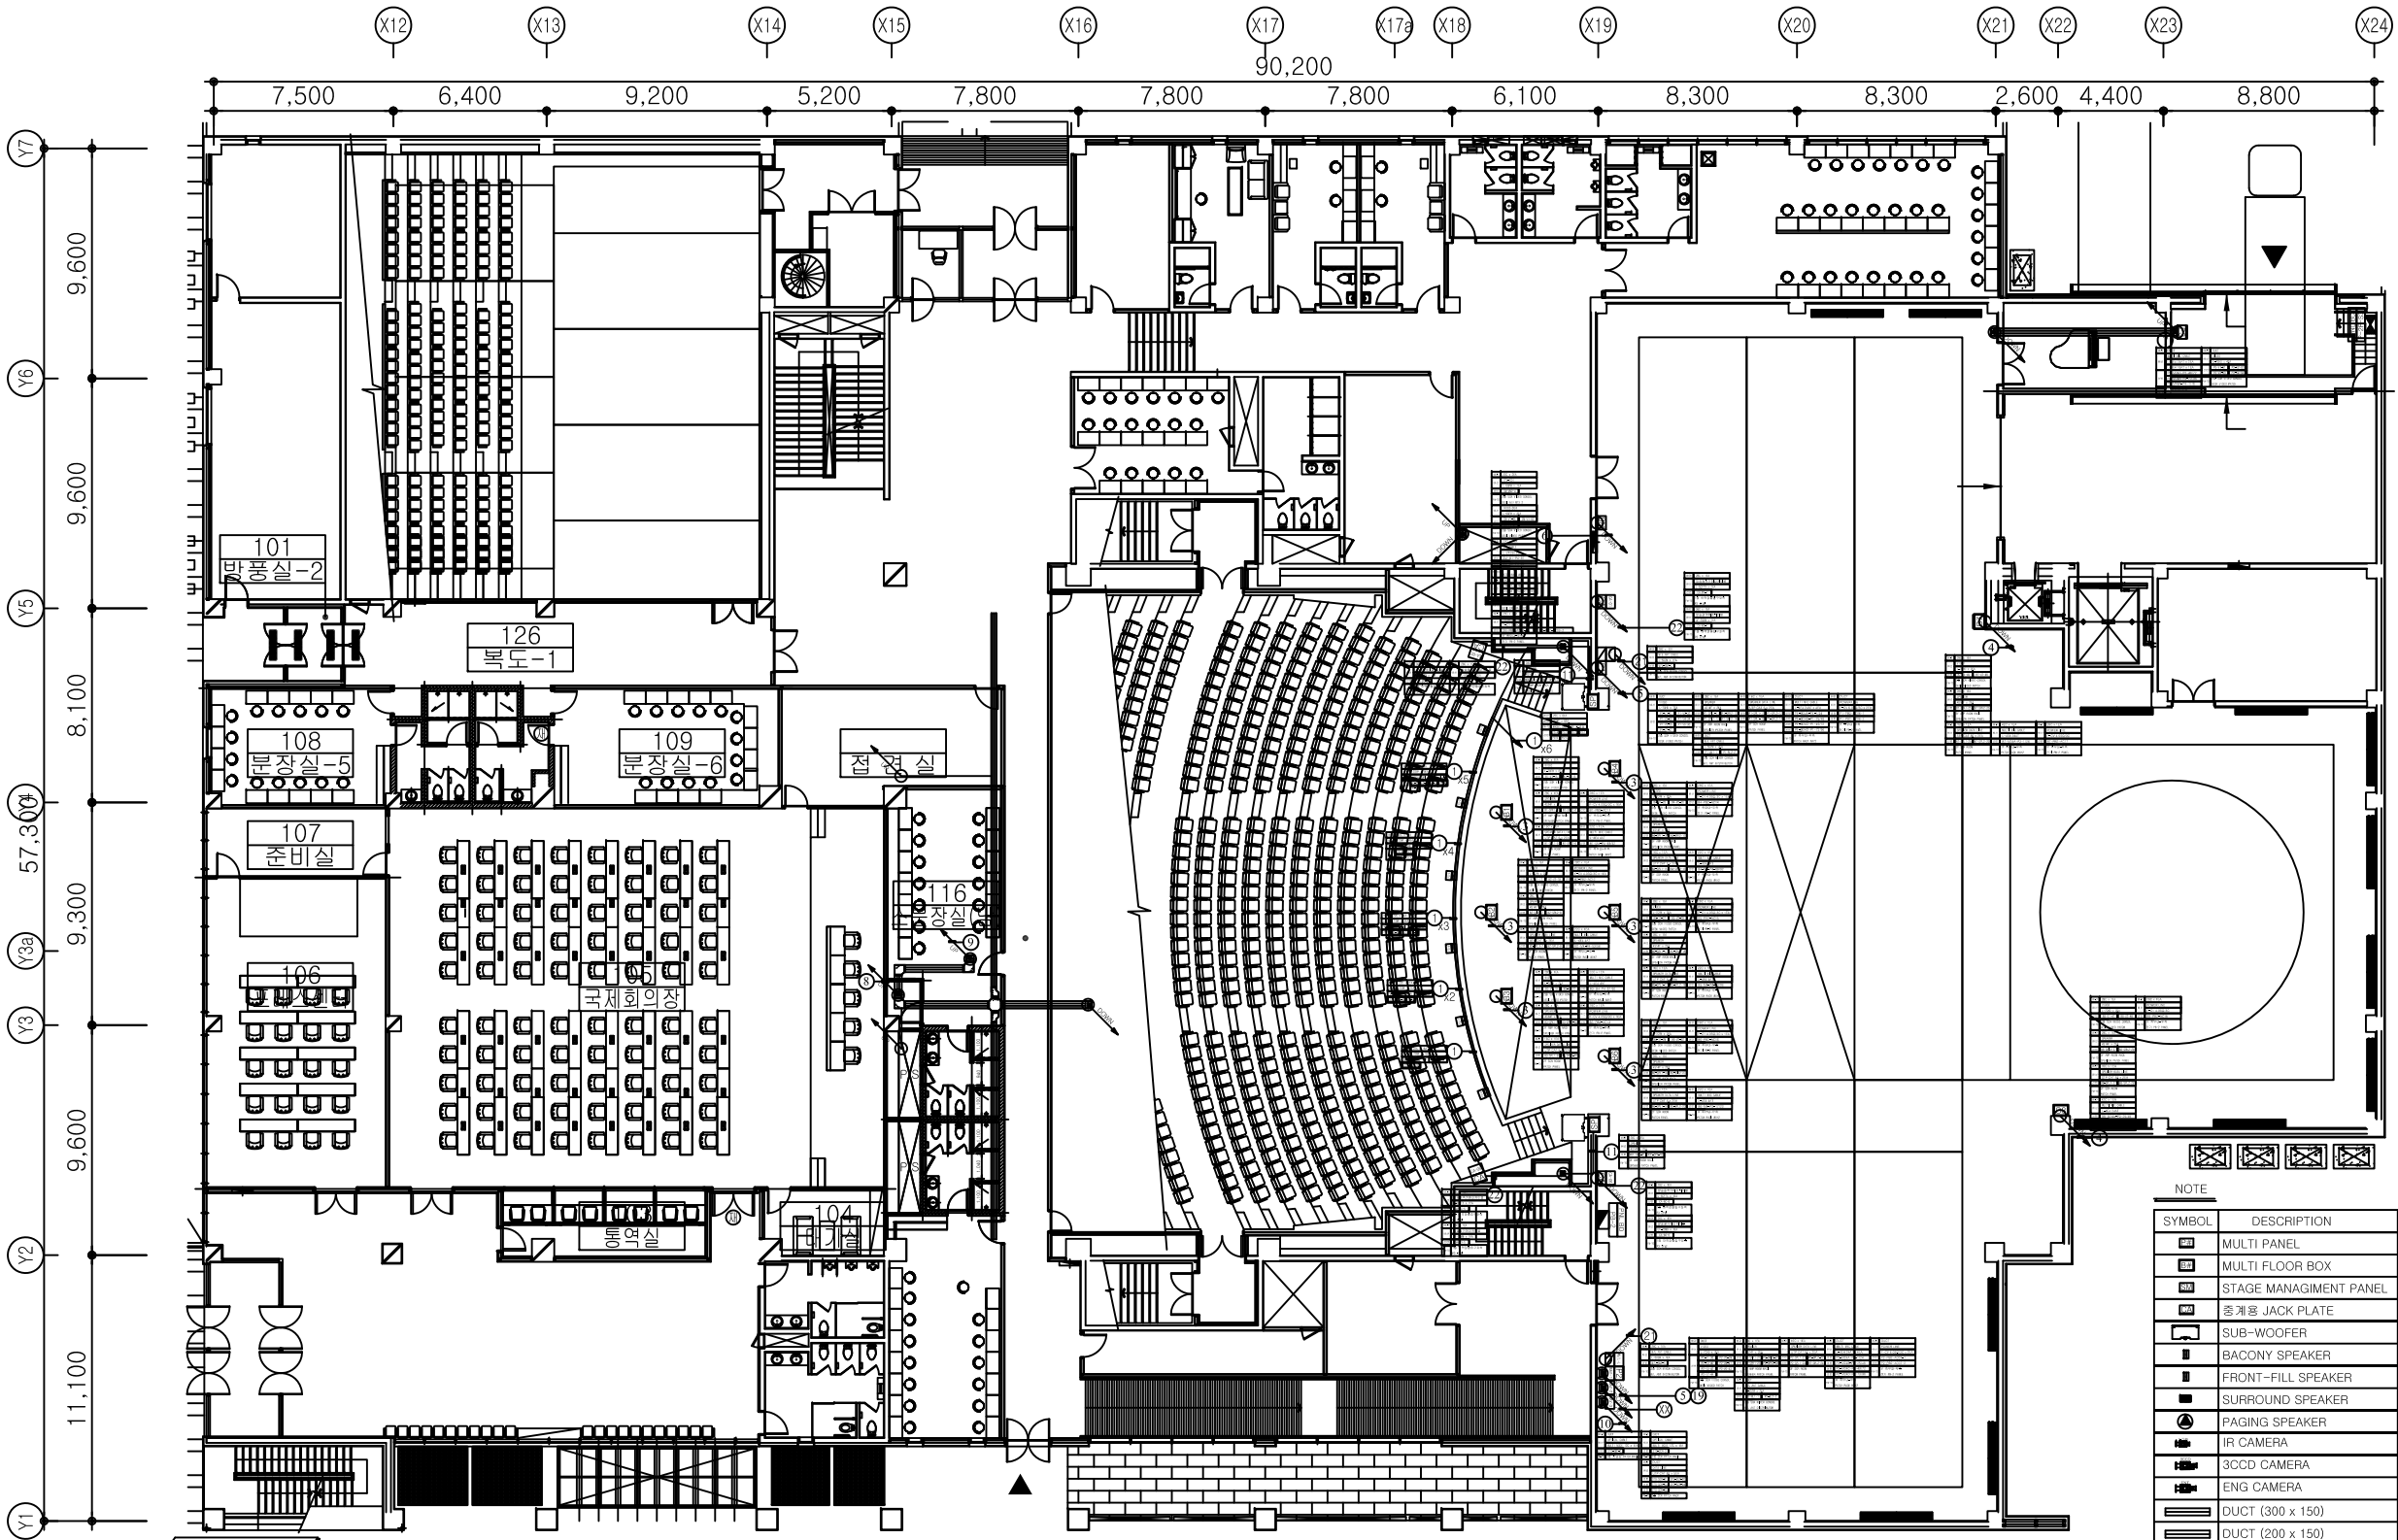

CABLE SCHEDULE

NO.	DESCRIPTION	CONDUIT	REMARK	NO.	DESCRIPTION	CONDUIT	REMARK	NO.	DESCRIPTION	CONDUIT	REMARK	NO.	DESCRIPTION	CONDUIT	REMARK
①	2S9F x 1EA	22C x 1EA	SPEAKER LINE	⑤	L-4E4 24AT x 4EA	42C x 4EA	MIC LINE	⑨	L-4E4 24AT x 5EA		MIC LINE	⑬	HIV 2.5 x 6EA	16C x 1EA	SPEAKER LINE
②	L-5CFTX x 1EA	28C x 1EA	CAMERA LINE	⑥	4S14F x 4EA	28C x 2EA	SPEAKER LINE	⑩	UTP CAT6 x 5EA		DATA LINE	⑭	L-4E4 4AT x 1EA	22C x 1EA	INTERCOM LINE
③	LF-2SM9 x 1EA	28C x 1EA	CAMERA LINE	⑦	L-7CHD x 7EA	36C x 7EA	VIDEO LINE	⑪	L-7CHD x 5EA		VIDEO LINE	⑮	L-5CFB x 1EA	16C x 1EA	TV LINE
④	L-4E4 4AT	22C x 1EA	MIC LINE	⑧	L-5D2W x 2EA	28C x 1EA	VIDEO LINE	⑫	DATA SHILD/25C x 1EA		CONTROL LINE	⑯	F-CV 2.5SQ/3C x 1EA	22C x 1EA	POWER LINE
⑤	4S14F x 2EA	28C x 1EA	SPEAKER LINE	⑨	UTP CAT.5 x 4EA	16C x 1EA	DATA LINE	⑬	F-CV 6SQ/4C x 1EA		POWER LINE	⑰	L-7CFB x 1EA	22C x 1EA	TV LINE
⑥	L-7CFB x 2EA	28C x 1EA	VIDEO LINE	⑩	F-CV 6.0SQ/3C x 2EA	28C x 2EA	POWER LINE	⑭	F-GV 6SQ/1C x 1EA		GROUND LINE	⑱	F-CV 2.5SQ/3C x 1EA	22C x 1EA	POWER LINE
⑦	UTP CAT.5 x 2EA	16C x 1EA	DATA LINE	⑪	L-2T2S x 2EA	16C x 1EA	MIC LINE	⑮	L-4E4 4AT x 12EA		MIC LINE	⑲	L-4E4 4AT x 2EA	28C x 1EA	INTERCOM LINE
⑧	F-CV 4.0SQ/3C x 1EA	28C x 1EA	POWER LINE	⑫	L-5CFB x 4EA	22C x 2EA	VIDEO LINE	⑯	L-4E4 12AT x 2EA		MIC LINE	⑳	L-4E4 4AT x 3EA		INTERCOM LINE
⑨	L-4E4 24AT	42C x 1EA	MIC LINE	⑬	F-CVVB 1.5SQ/5C x 1EA	28C x 1EA	CONTROL LINE	⑰	L-4E4 16AT x 2EA		MIC LINE	㉑	L-4E4 4AT x 4EA		INTERCOM LINE
⑩	4S14F x 2EA	28C x 1EA	SPEAKER LINE	⑭	F-CV 2.5SQ/3C x 2EA	22C x 2EA	POWER LINE	⑱	L-4E4 24AT x 19EA		MIC LINE	㉒	L-5D2W x 1EA	28C x 1EA	W/L ANT LINE
⑪	L-7CFB x 2EA	28C x 1EA	VIDEO LINE	⑮	L-4E4 16AT x 1EA	36C x 1EA	MIC LINE	㉓	MULTI MODE 12C x 1EA		OPTICAL LINE				
⑫	UTP CAT.5 x 2EA	16C x 1EA	DATA LINE	⑯	L-4E4 24AT x 2EA	42C x 2EA	MIC LINE	㉔	F-CV 2.5SQ/3C x 1EA		POWER LINE				
⑬	F-CV 4.0SQ/3C x 1EA	28C x 1EA	POWER LINE	⑰	L-7CHD x 4EA	36C x 4EA	VIDEO LINE	㉕	8S15-SC x 2EA	28C x 2EA	SPEAKER LINE				
⑭	L-5CFTX x 1EA	28C x 1EA	CAMERA LINE	⑱	L-5CFTX x 8EA	28C x 8EA	CAMERA LINE	㉖	HIV 2.5 x 2EA	16C x 1EA	SPEAKER LINE				
⑮	LF-2SM9 x 1EA	28C x 1EA	CAMERA LINE	㉑	LF-2SM9 x 8EA	28C x 8EA	CAMERA LINE	㉗	HIV 2.5 x 4EA	16C x 1EA	SPEAKER LINE				

대공연장 음향설비 배관배선 평면도(1층)

NOTE

KEY PLAN

REV NO	REV DESCRIPTION	DATE	APP

ADD
Architecture Planning Interiors
(주)종합건축사사무소 에이디디
TEL: 02)3453-5671
FAX: 02)766-6793

APPROVED	승인
SUBJECTED	심사
CHECKED	검토
DRAWING	설계
구조	상우구조
TEL	02)2024-2340 FAX 02)2108-2460
기계	목원ENG
TEL	02)2108-2345 FAX 02)2108-2460
전기	나라기술단
TEL	02)511-2041
토목	다산 ENG
TEL	02)873-6005 FAX 02)873-9056
조경	민조경
TEL	02)3446-9247 FAX 02)3446-9249

시공사

현장대리인 계 송 철 (인)

건설사업관리단

사업관리단장 국 광 호 (인)

통 신 한 성 수 (인)

PROJECT TITLE
안동문화예술의 전당
민간투자시설사업

DRAWING TITLE 도면명
대공연장 음향설비
배관배선 평면도(1층)

SCALE 축척
A1 : 1/150
A3 : 1/300
DATE 날짜
2010. 07.

DRAWING NO.
도면번호
SS-010

SHEET NO.
시트번호